


© Bechtel Corporation 2008. All rights reserved. Bechtel Confidential. Contains information that is confidential and proprietary to Bechtel and may not be used, reproduced, or disclosed in any format without Bechtel's prior written permission. This document is prepared exclusively for Gassnova in connection with the preparation of the FEED study for the CO2 Capture Facility at Kårstø, Norway, and is not to be relied upon by others or used in connection with any other project.

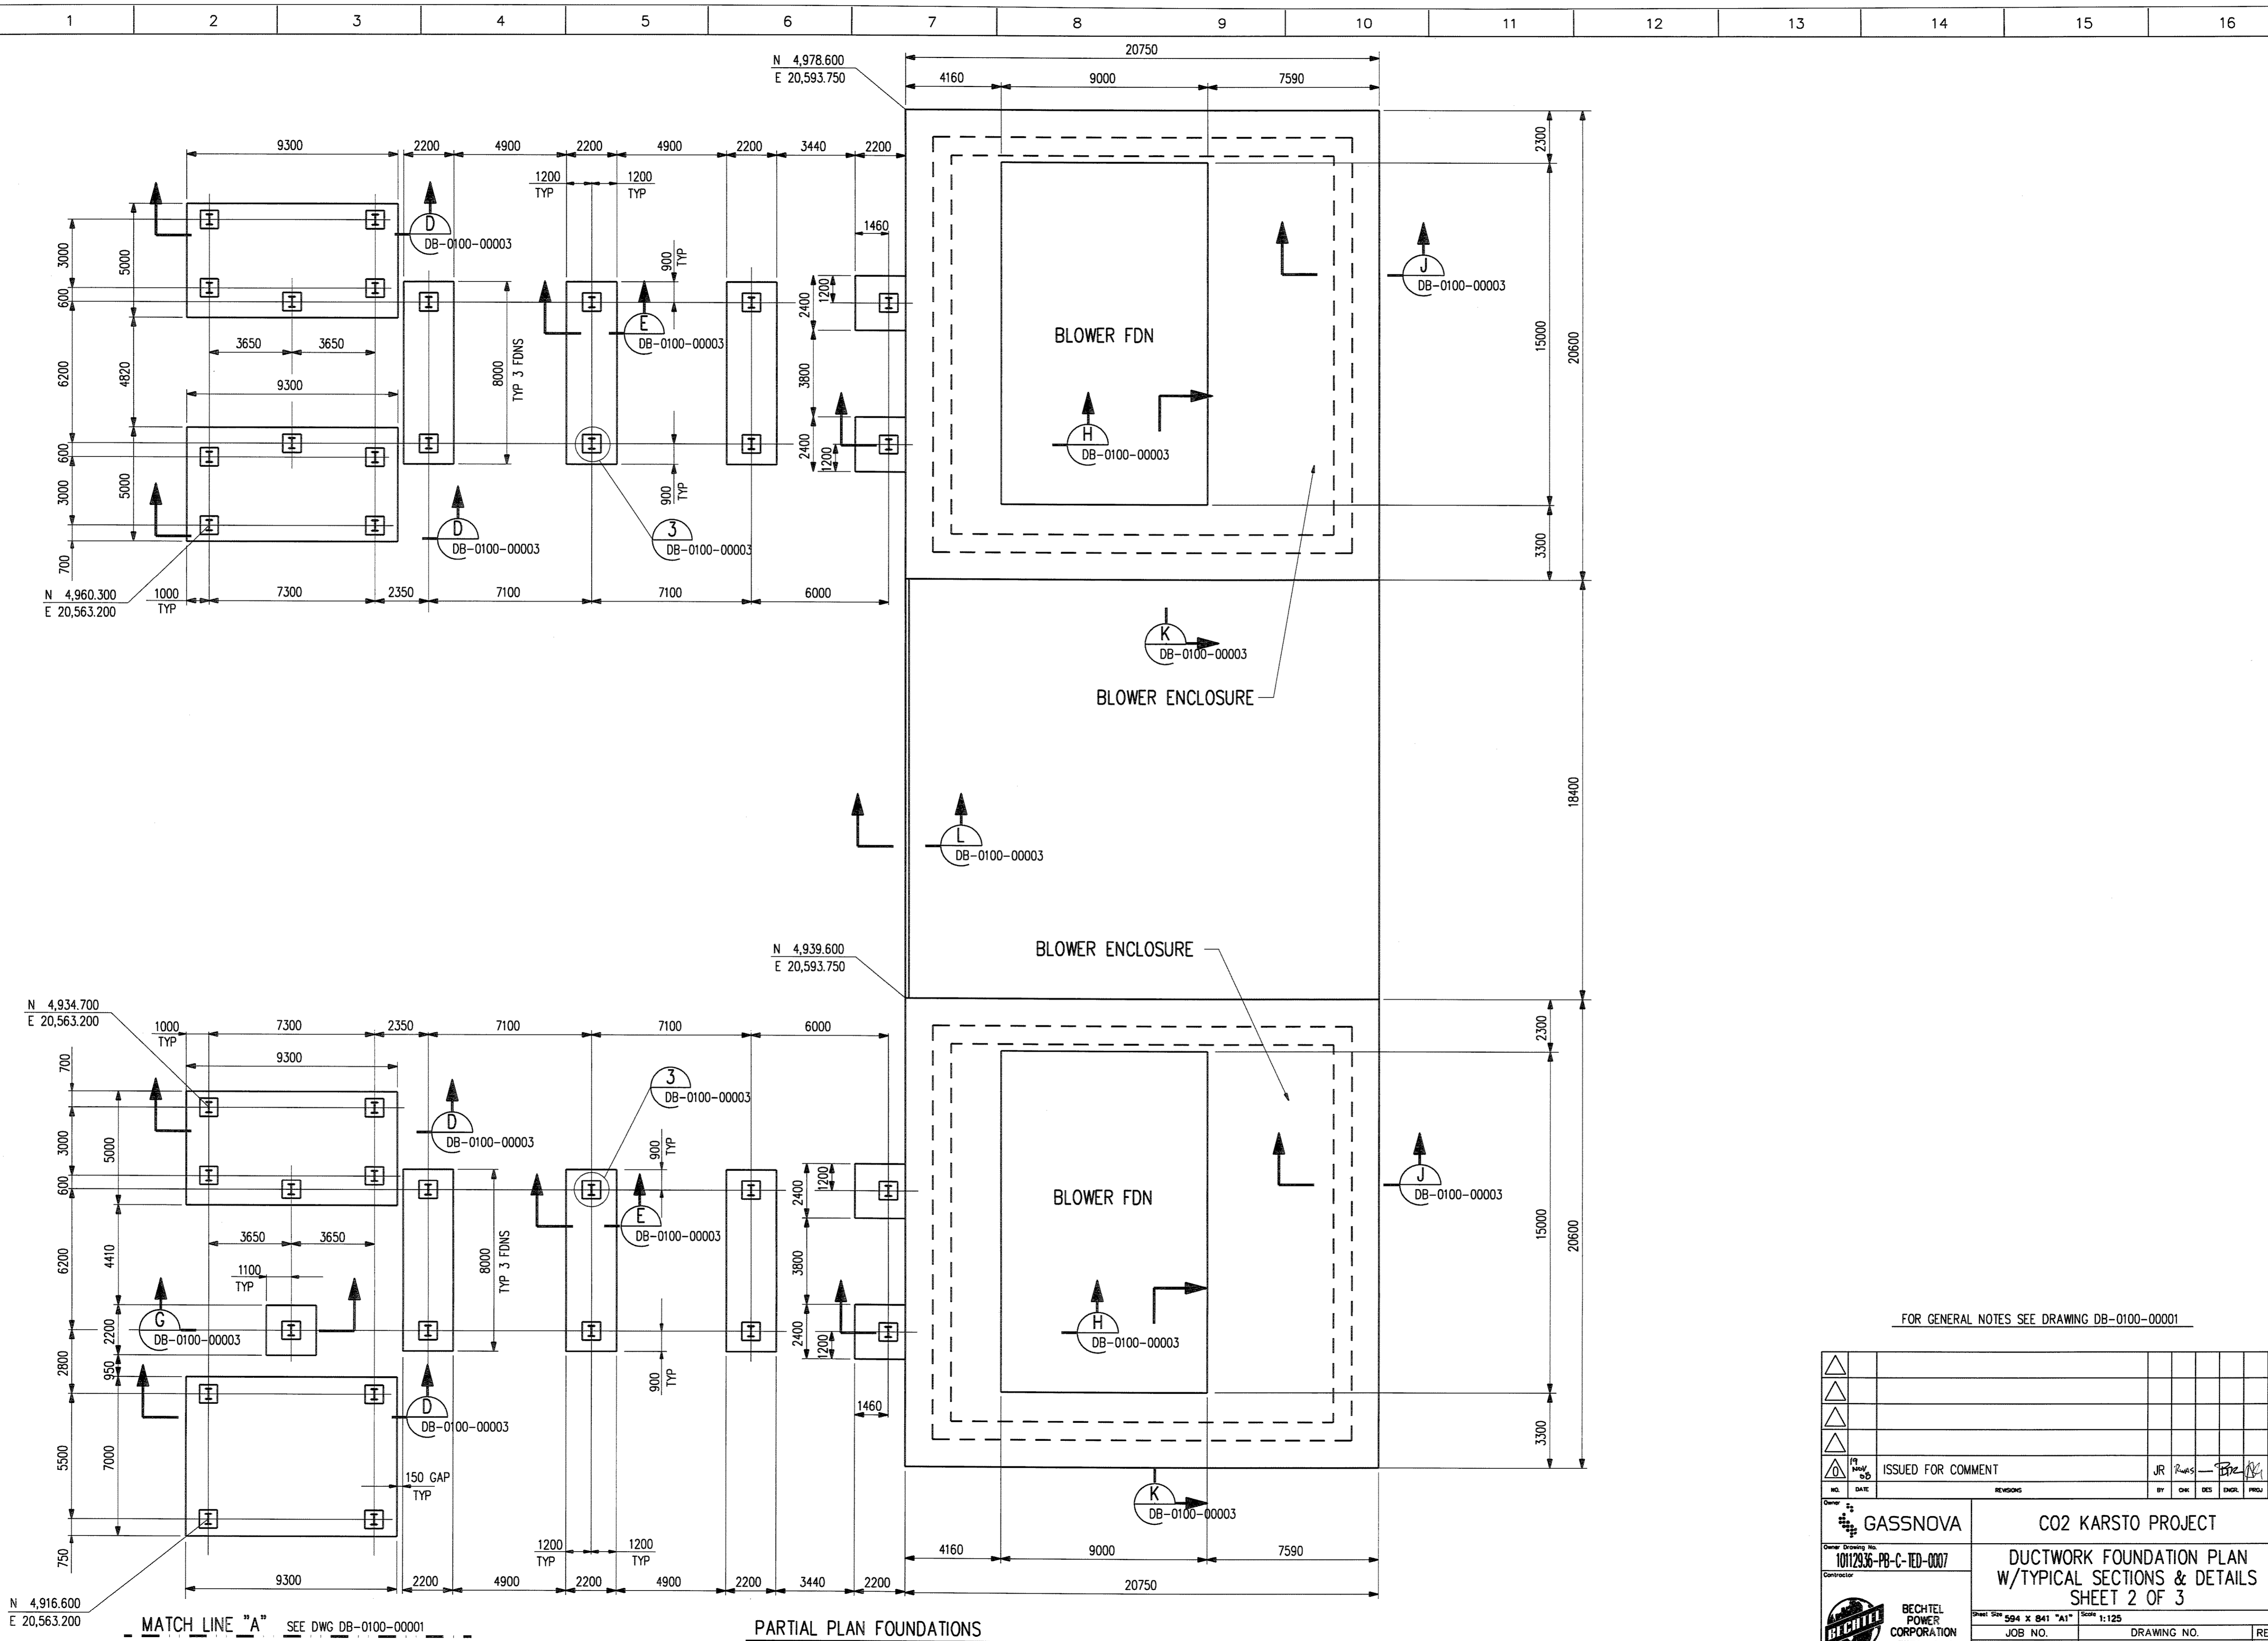

FOR GENERAL NOTES SEE DRAWING DB-0100-00001

NO.	DATE	REVISIONS	BY	CHK	DES	ENGR	PROJ	APPR
ISSUED FOR COMMENT			JR	PL				
Owner Drawing No. 10112936-PB-C-RED-0007		GASSNOVA CO2 KARSTO PROJECT						
Contractor BECHTEL POWER CORPORATION		DUCTWORK FOUNDATION PLAN W/TYPICAL SECTIONS & DETAILS SHEET 2 OF 3						
Sheet Size 594 X 841 "A1" Scale 1:125		JOB NO. 25474-000		DRAWING NO. DB-0100-00002		REV. 0		

MATCH LINE "A" SEE DWG DB-0100-00001

PARTIAL PLAN FOUNDATIONS